


INDICATIVE PLAN VIEW

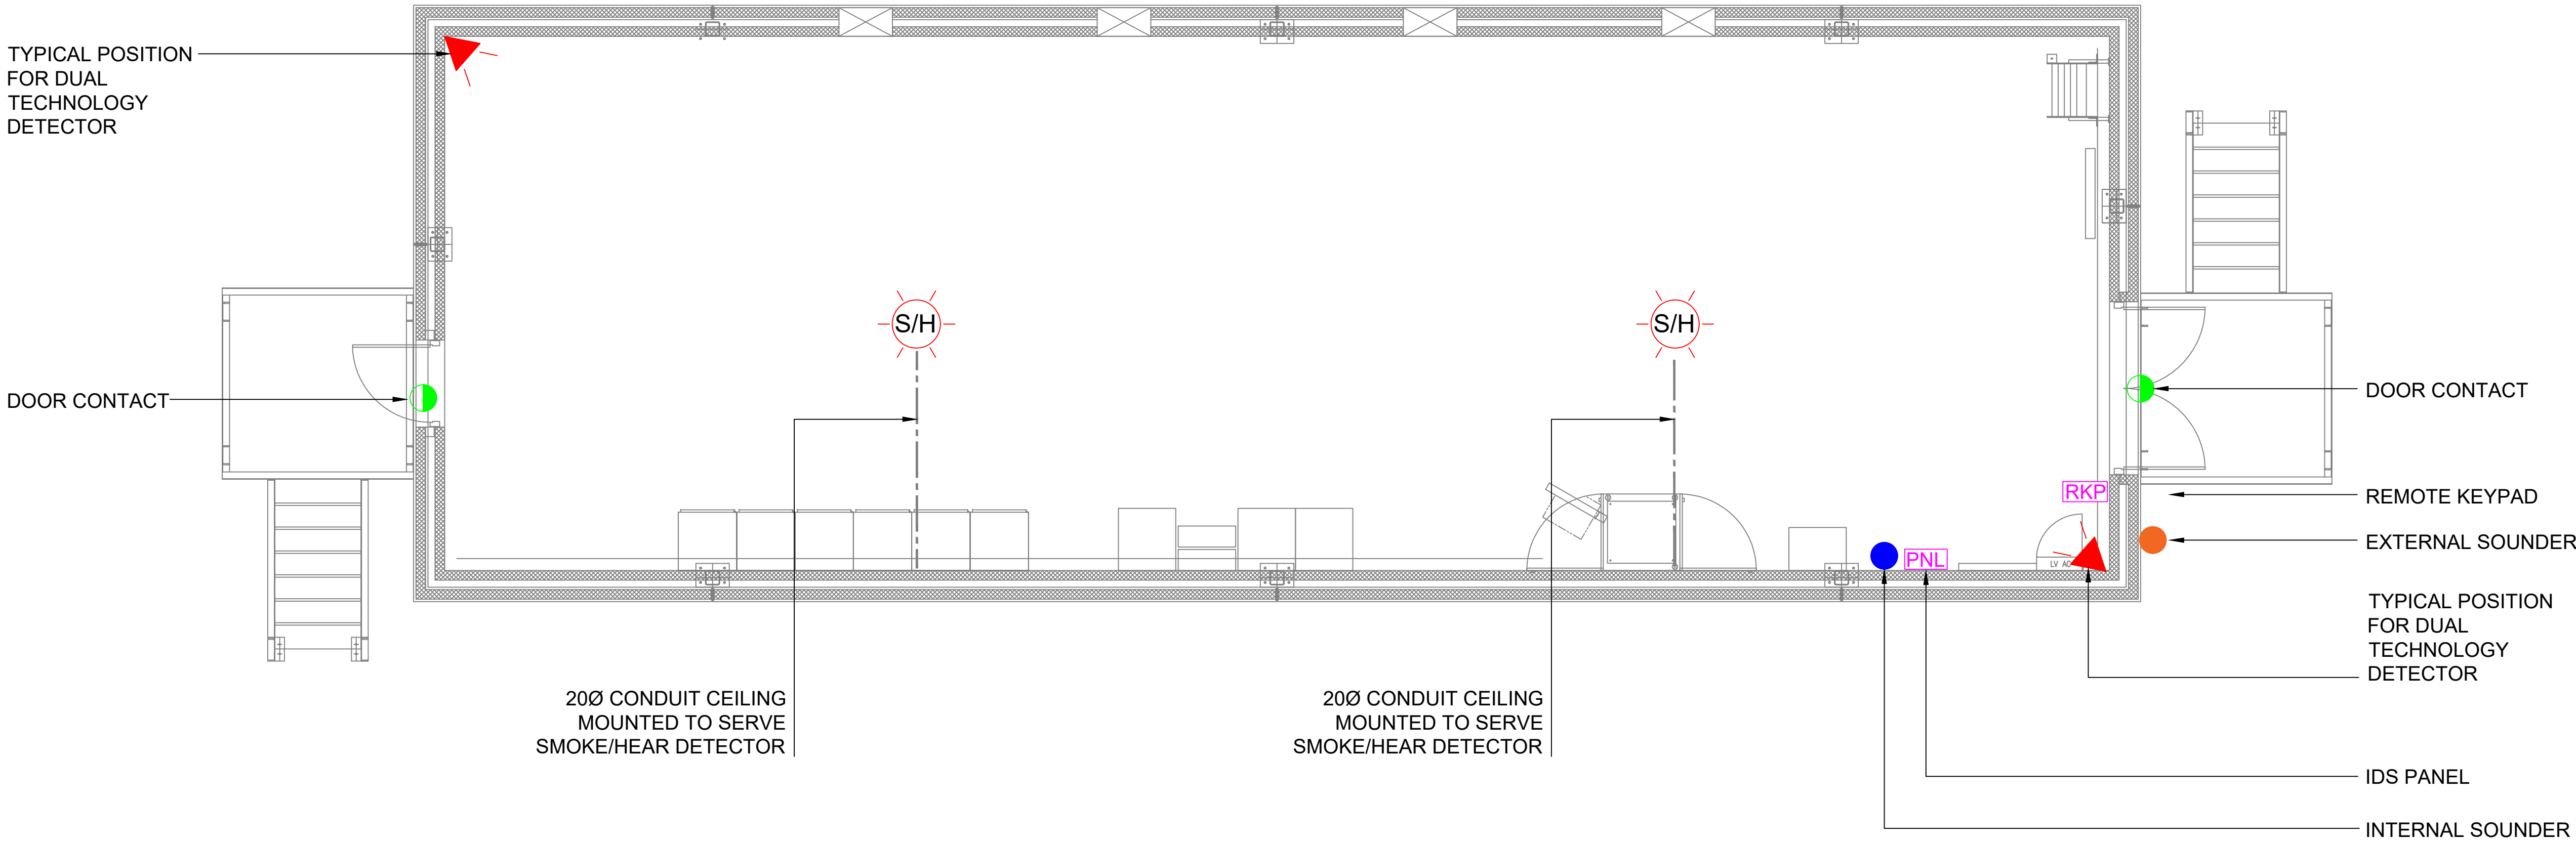

NOTES:

THIS DOCUMENT HAS FULL RESTRICTED STATUS AND MUST ONLY BE RELEASED IN ACCORDANCE WITH APPLICABLE SECURITY PROCEDURES

RELIANCEHIGH-TECH LTD IS THE OWNER OF ALL INTELLECTUAL PROPERTY RIGHTS OF THIS DRAWING. THIS DRAWING MAY NOT BE ALTERED, REPRODUCED OR USED OTHER THAN FOR THE CONTRACT WORKS FOR WHICH IT IS ISSUED WITHOUT THE WRITTEN PERMISSION OF RELIANCEHIGH-TECH LTD.

THIS IS A COLOURED DRAWING AND SHOULD BE TREATED AS MASTER IF THIS TEXT IS RED.

3.0	ACCESS REQUIREMENTS	DLB	IB	30.05.23
2.0	COMMENTS INCORPORATED	DLB	IB	23.05.23
1.0	ISSUED FOR COMMENT	DLB	IB	19.05.23
REV	AMENDMENTS	DRN	APP	DATE



Site:	NGED TYPICAL							
Dwg.	Security Layout							
Title:	Telemetry Kiosk Indicative Equipment Layout							
Dwg No:	NGED TYPICAL COMMS LAYOUT							
SHEET	1	of	1					
Drawn By	DATE		SCALE		PAPERSIZE		REV	
DLB	30/05/2023		NTS		A1		3.0	
Do not scale off this drawing. Check all dimensions on site								
0mm 10mm			100mm					
Original Scale 1:1								