


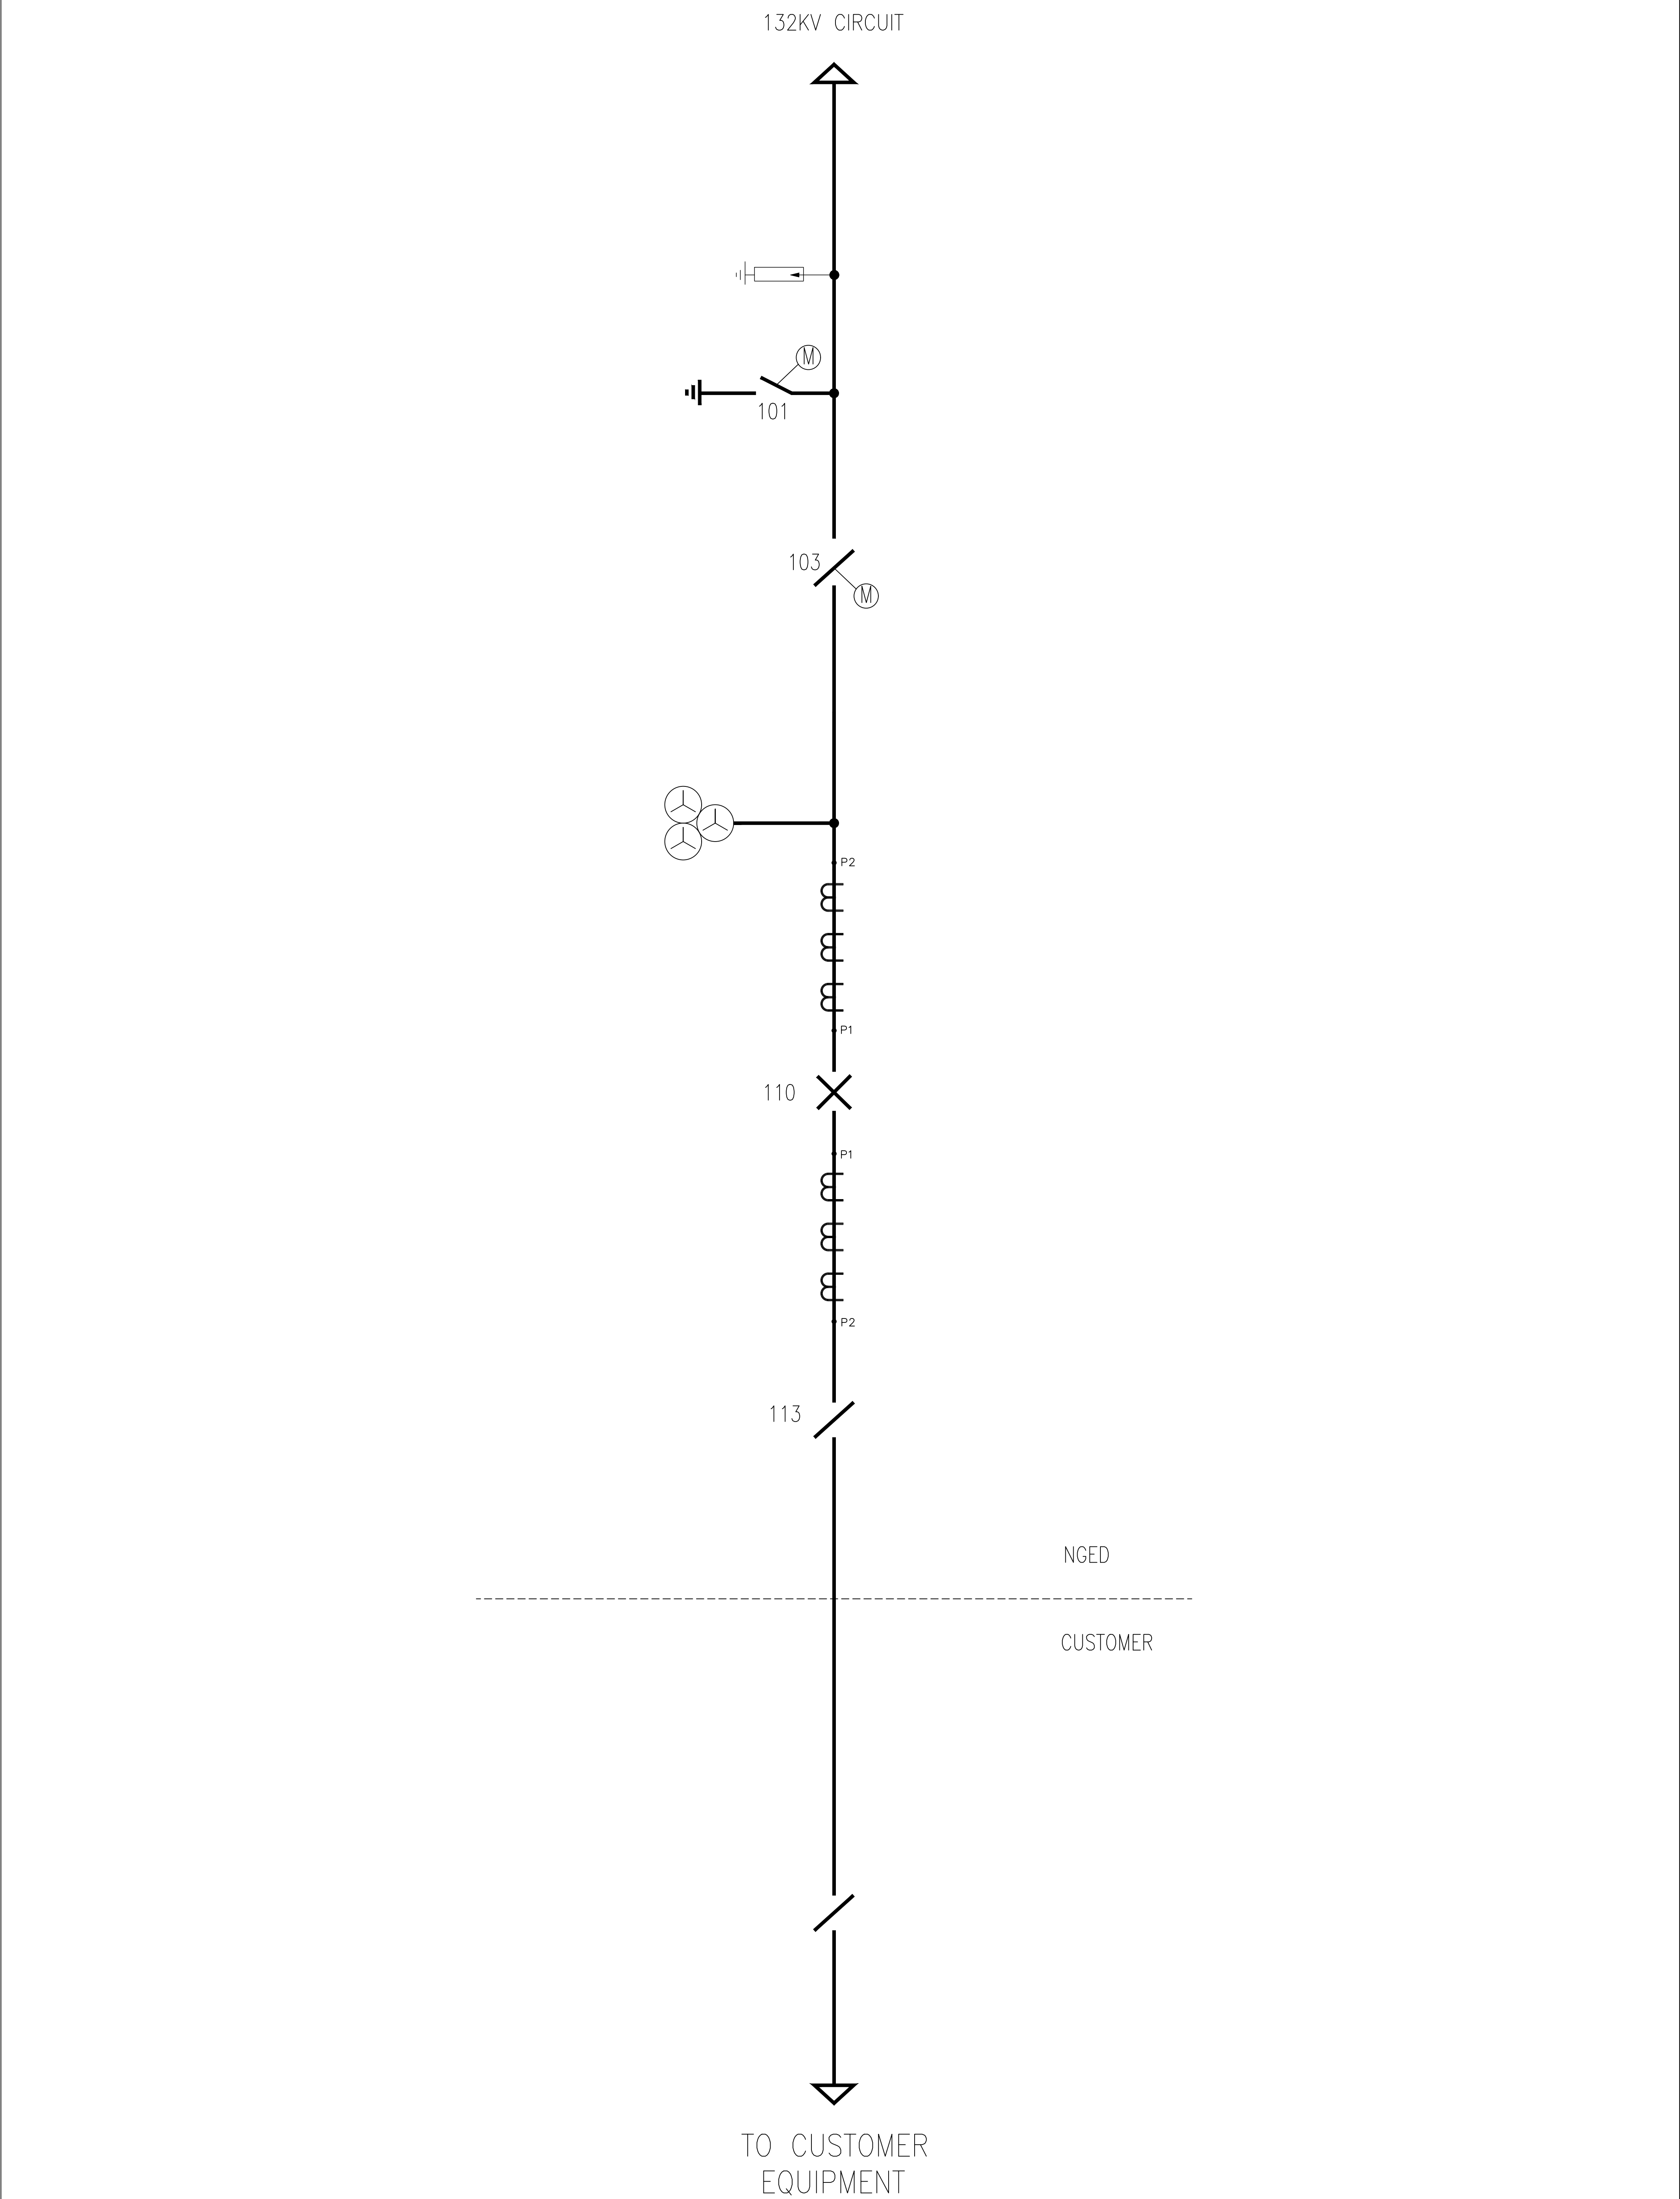

						nationalgrid Electricity Distribution		Engineering Design Department (East Midlands) Pegasus Business Park, Castle Donington, DE74 2TU.				
						Title:NGED 145KV STANDARDS TEED CONNECTION TEE OFF SUBSTATION SINGLE LINE DIAGRAM		Scale: NTS @A1	Drg. No. GCS0019-6	Rev No. 0		
0	PJB	KRS	CH	03.11.23	ORIGINAL ISSUE							
Rev	Drawn	Chk'd	App'd	Date	Revision Note							