


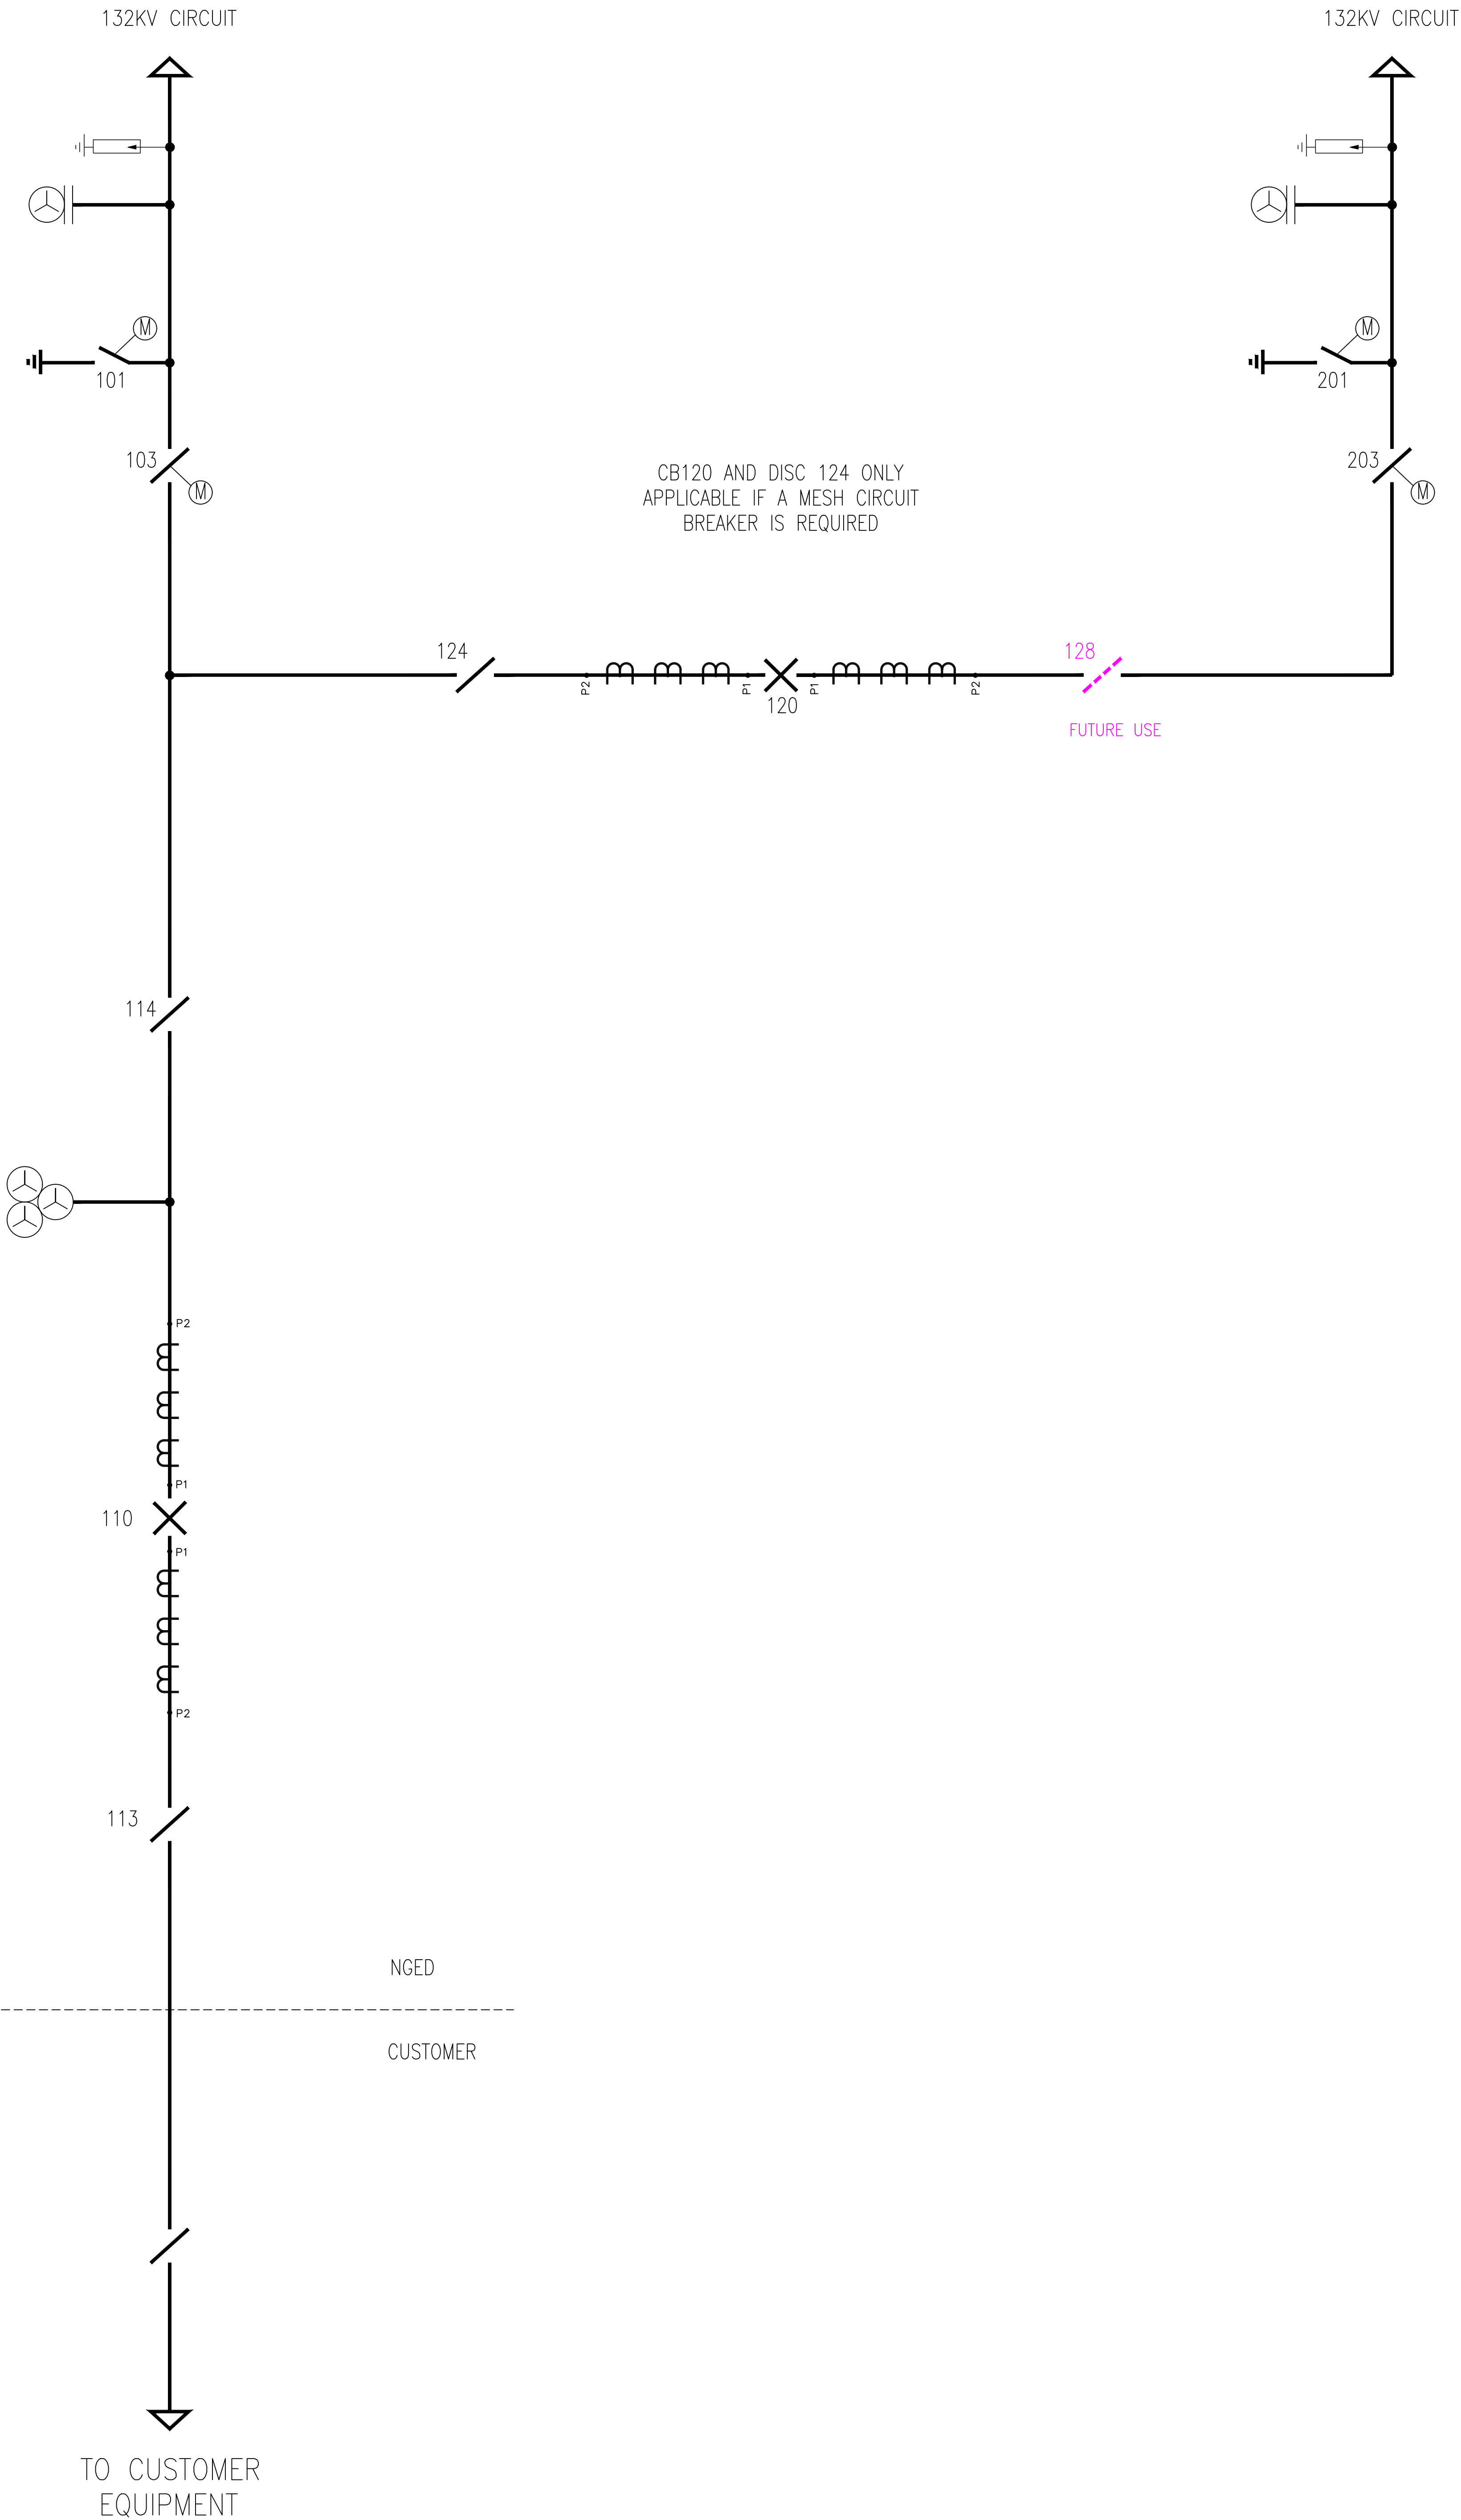

|     |       |       |       |          |                |                                                                                                                   |  |                                                                                                     |                               |                      |  |  |  |  |  |
|-----|-------|-------|-------|----------|----------------|-------------------------------------------------------------------------------------------------------------------|--|-----------------------------------------------------------------------------------------------------|-------------------------------|----------------------|--|--|--|--|--|
|     |       |       |       |          |                | <div><div>nationalgrid</div><div>Electricity Distribution</div></div>                                             |  | Engineering Design Department (East Midlands)<br>Pegasus Business Park, Castle Donington, DE74 2TU. |                               |                      |  |  |  |  |  |
|     |       |       |       |          |                | Title: <div>NGED 145KV STANDARDS<br/>LOOP IN-LOOP OUT CONNECTION<br/>LOOP IN SUBSTATION SINGLE LINE DIAGRAM</div> |  | Scale: <div>NTS @A1</div>                                                                           | Drg. No. <div>GCS0020-6</div> | Rev No. <div>0</div> |  |  |  |  |  |
|     |       |       |       |          |                |                                                                                                                   |  |                                                                                                     |                               |                      |  |  |  |  |  |
|     |       |       |       |          |                |                                                                                                                   |  |                                                                                                     |                               |                      |  |  |  |  |  |
| 0   | PJB   | KRS   | CH    | 03.11.23 | ORIGINAL ISSUE |                                                                                                                   |  |                                                                                                     |                               |                      |  |  |  |  |  |
| Rev | Drawn | Chk'd | App'd | Date     | Revision Note  |                                                                                                                   |  |                                                                                                     |                               |                      |  |  |  |  |  |