
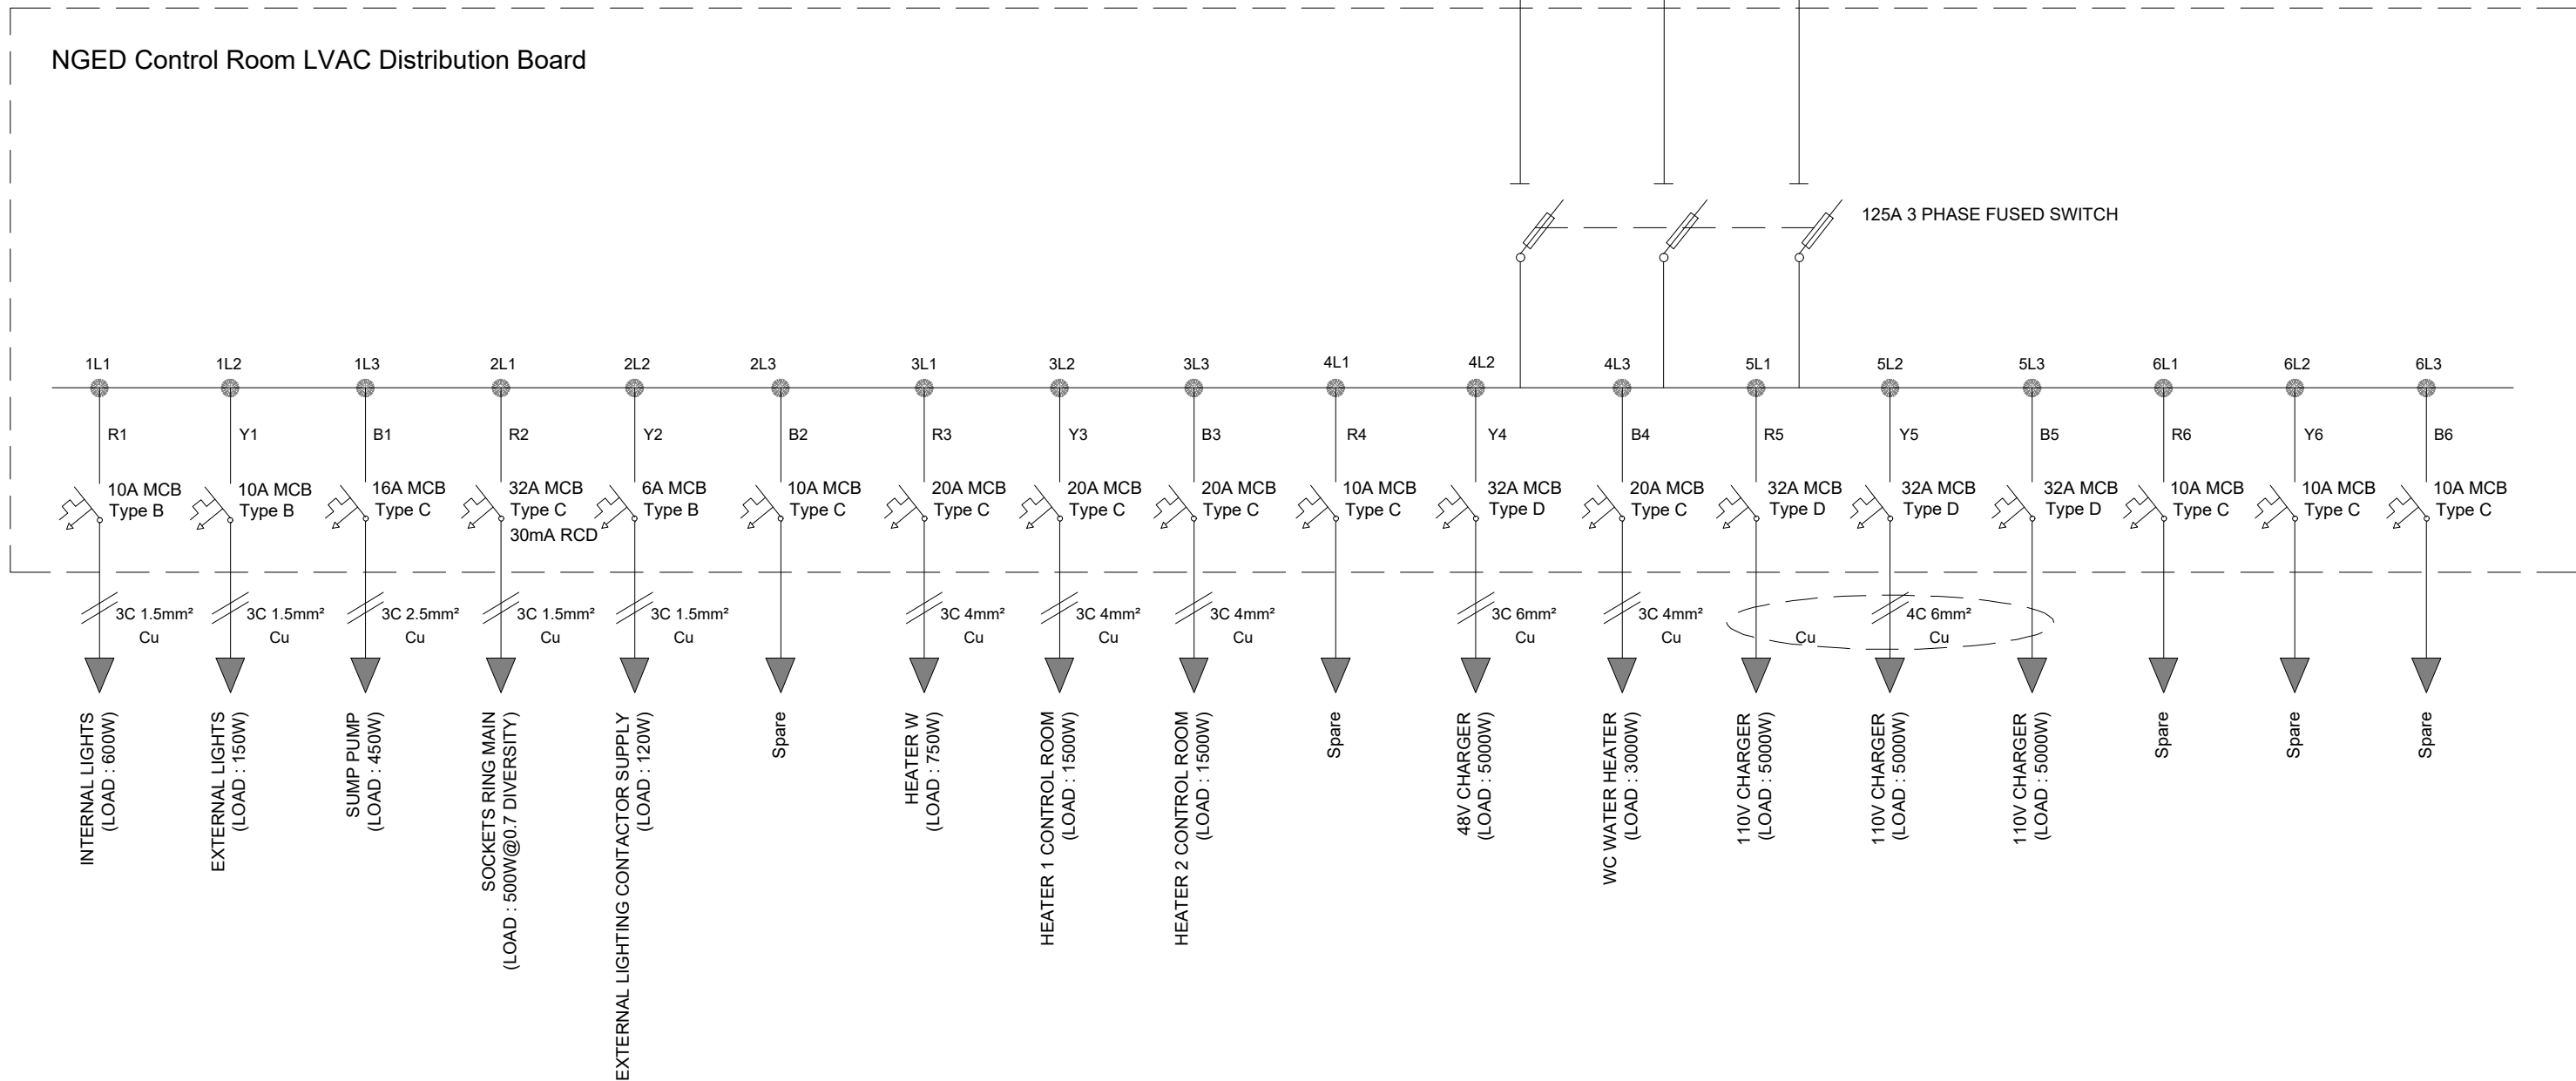


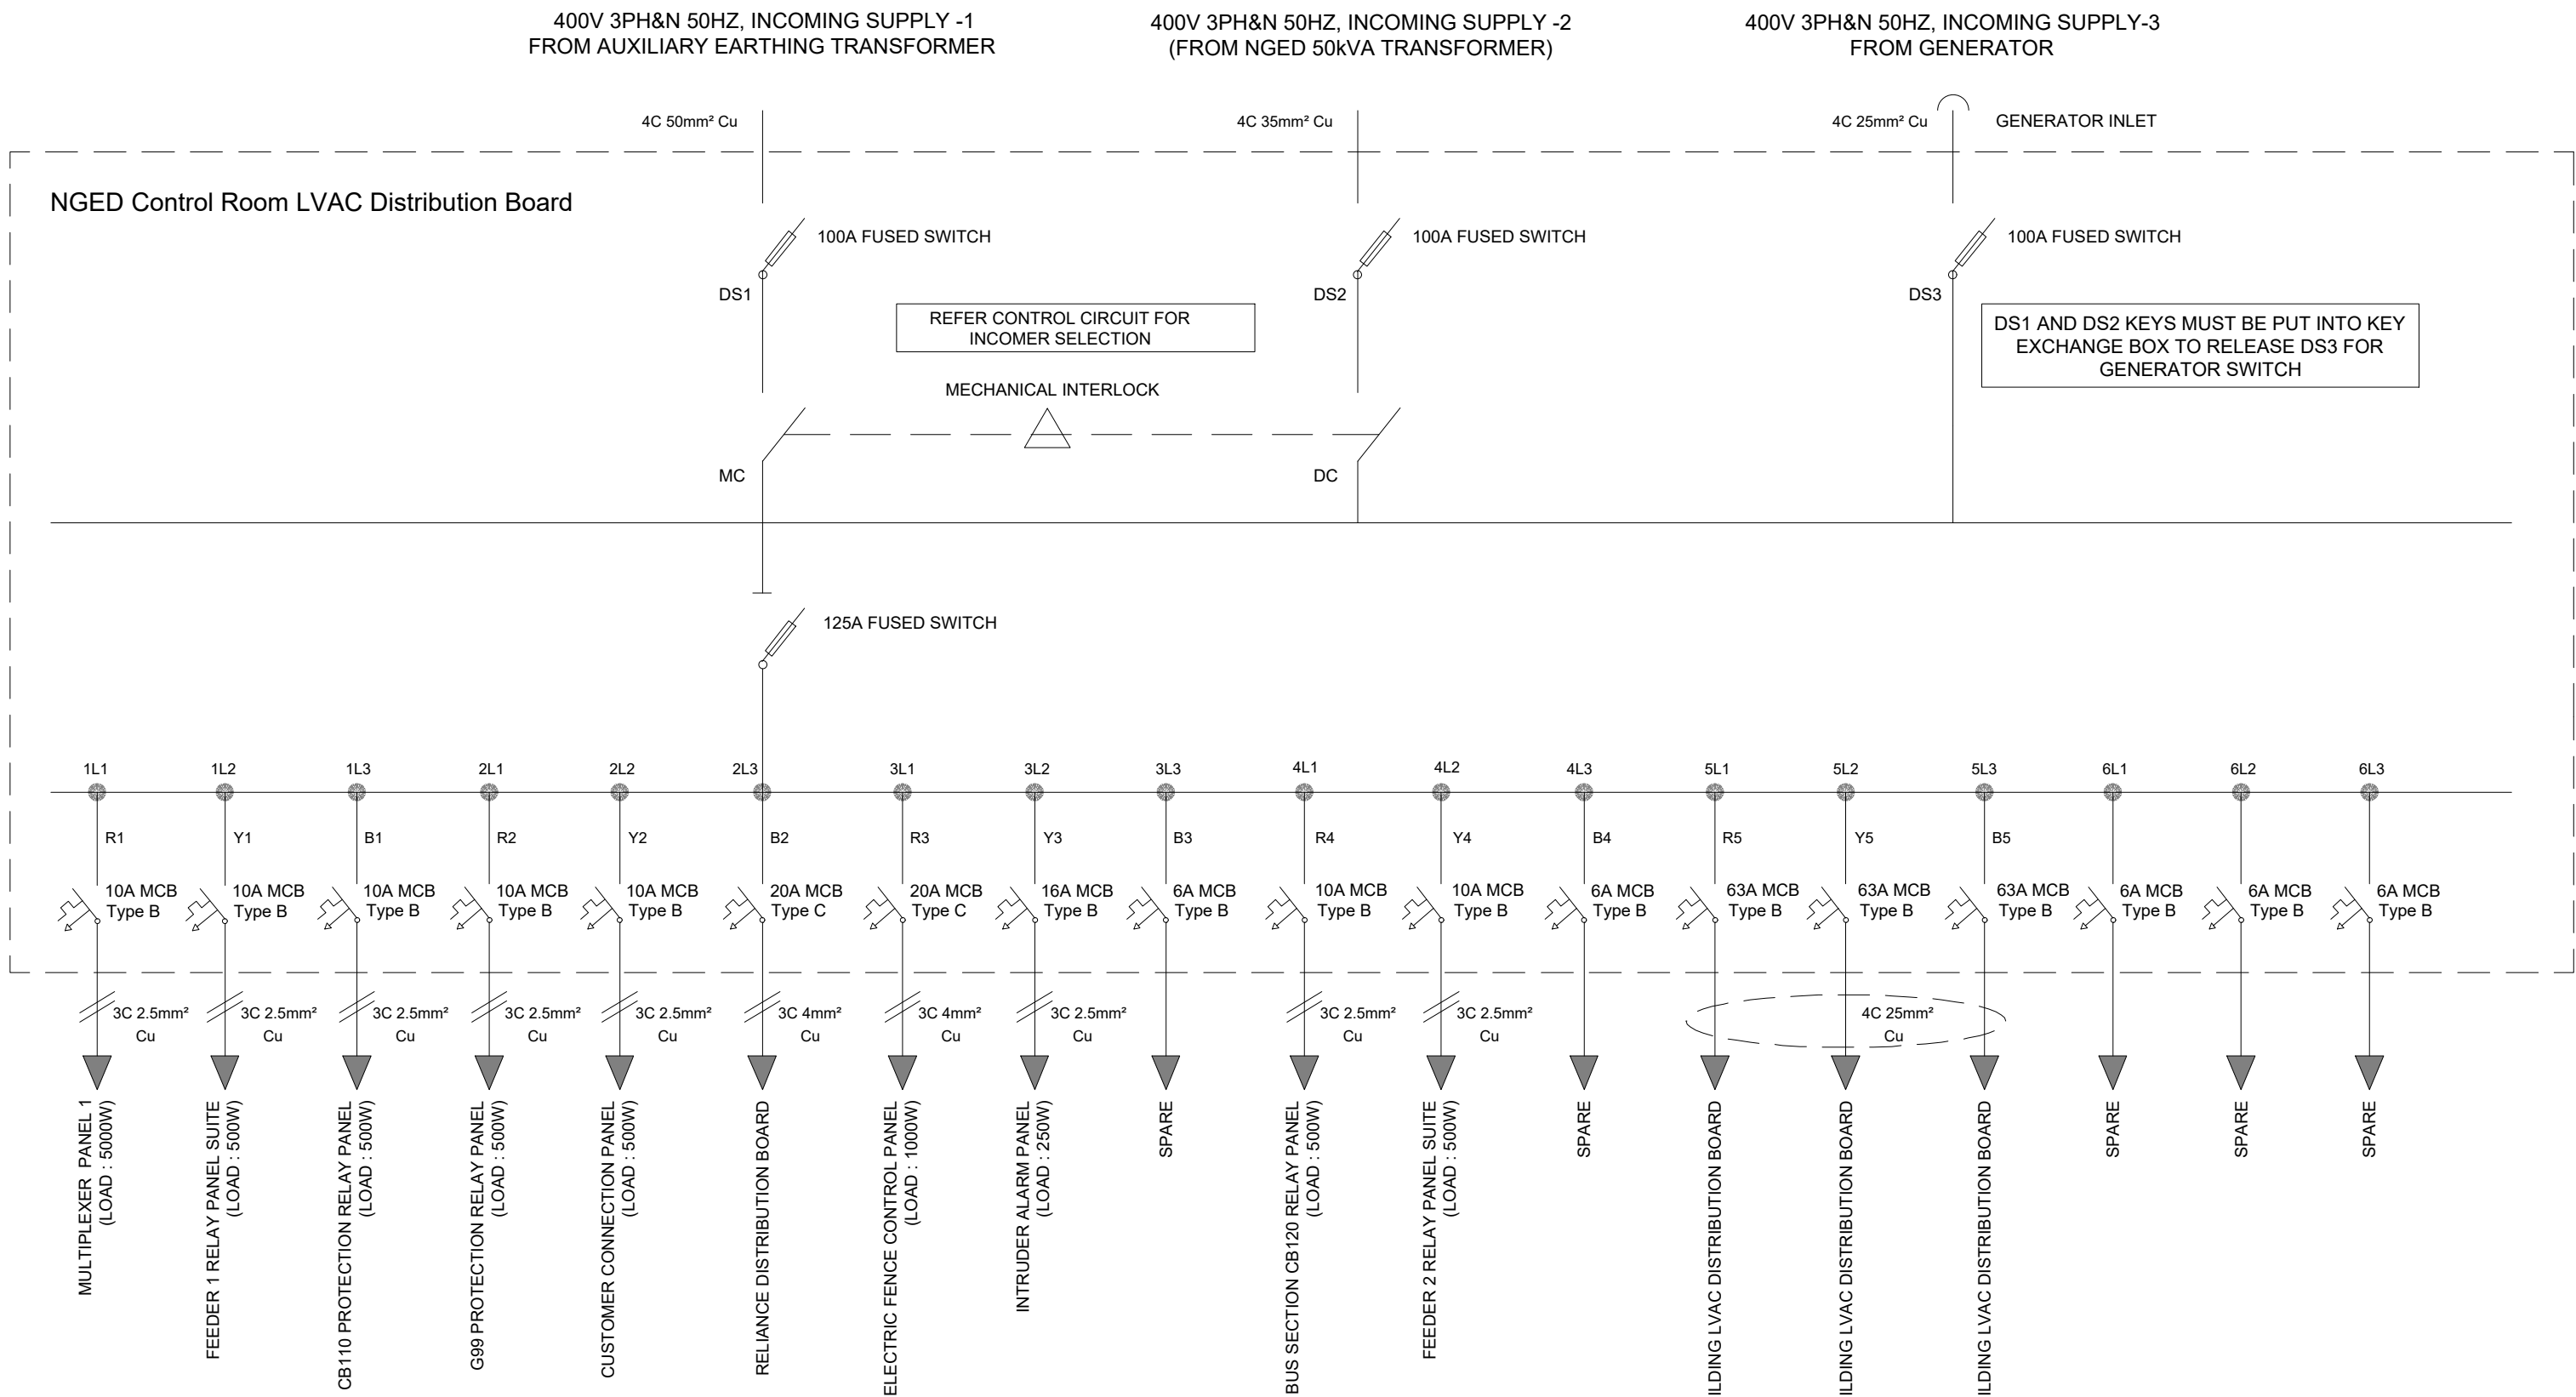


Note :

All work and testing shall be carried out by suitably competent operative in accordance with BS 7671.

All labelling shall comply with BS 7671

All Distribution board ways shall be permanently labelled to identify circuit function, cable size and Protective device rating.

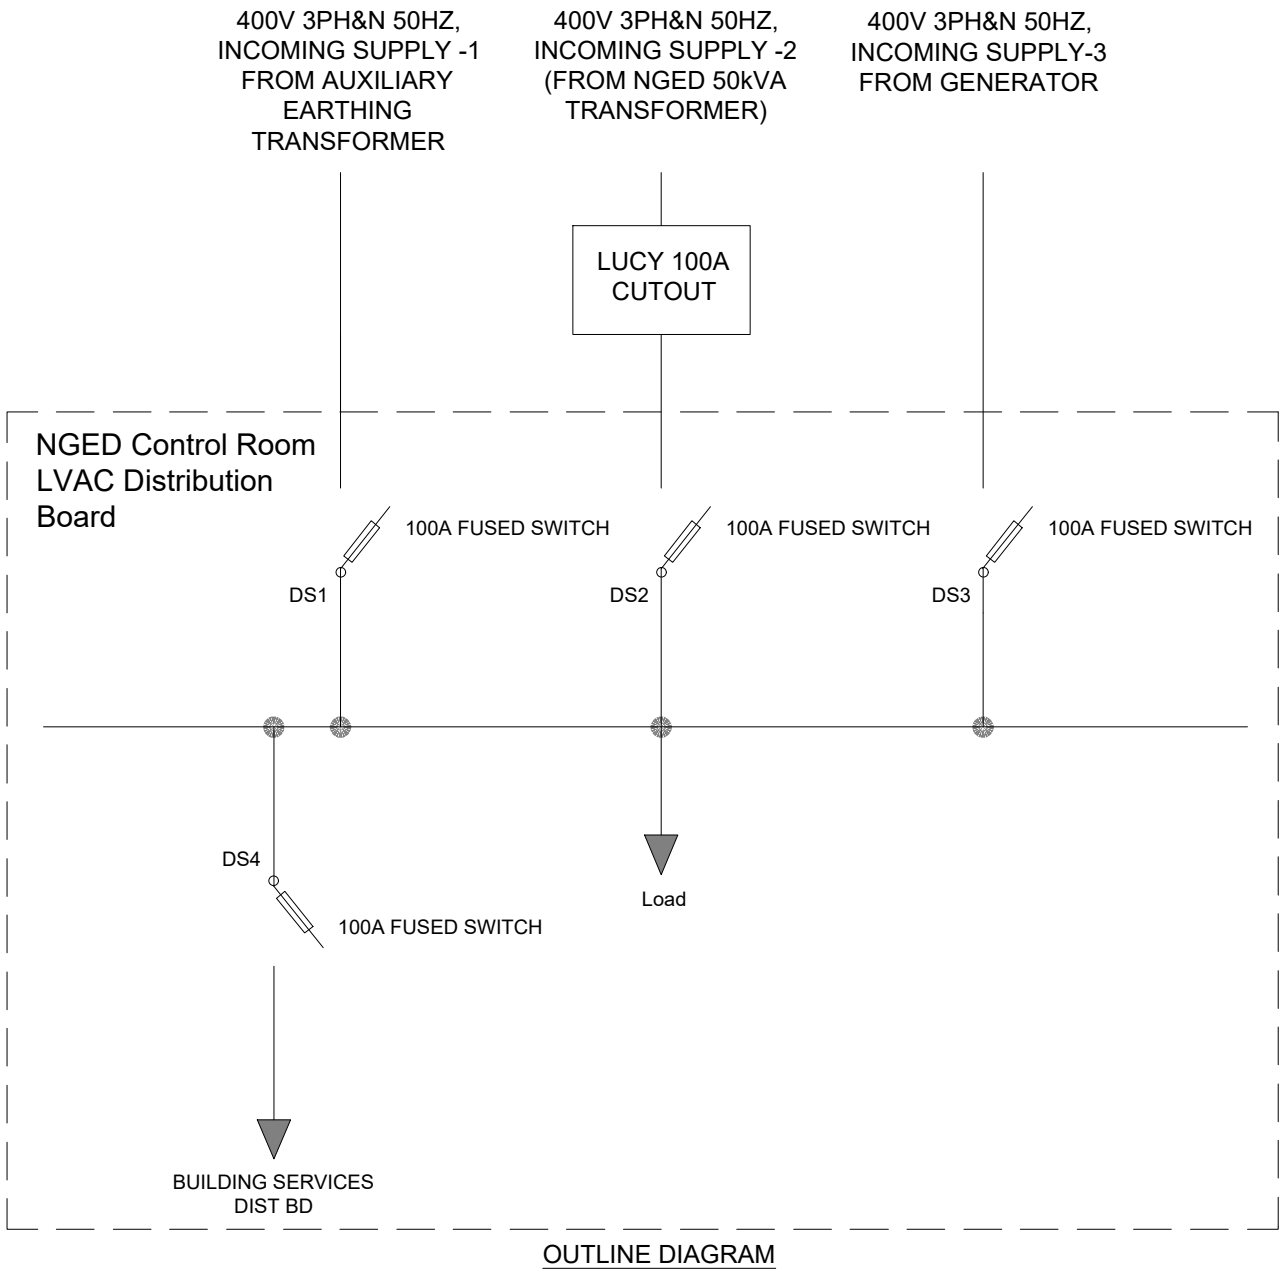

Rev	Drawn	Chk'd	App'd	Date

Revision Note

Revision Note



Engineering Design Department (East Midlands)
Pegasus Business Park, Castle Donington, DE74 2TU.

Title: NGED 145KV STANDARDS
LOOP IN-LOOP OUT CONNECTION
LOOP IN SUBSTATION LVAC SINGLE LINE DIAGRAM

Scale: NTS@A1

Drg. No. GCS0020-8

Rev No. 0